


FIGURE 1.1.1

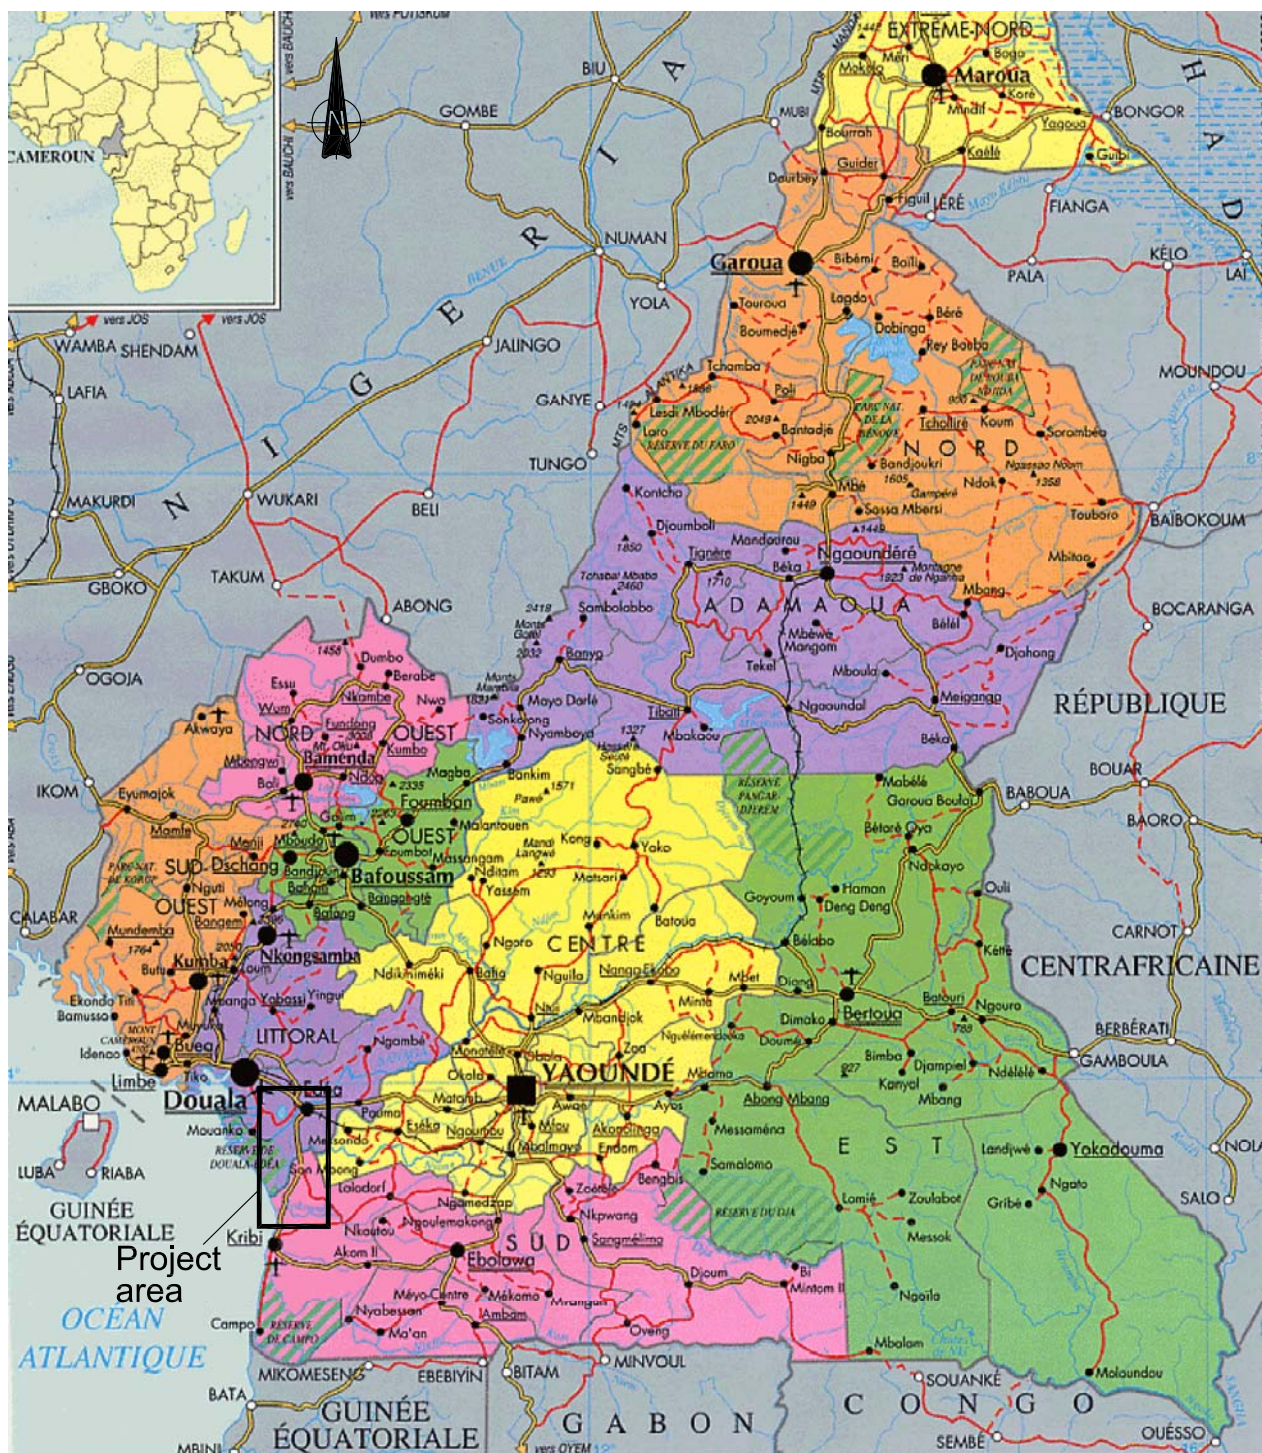


AES SONEL

KRIBI POWER PROJECT ESIA

PROJECT LOCATION PLAN



Scott Wilson
www.scottwilson.com

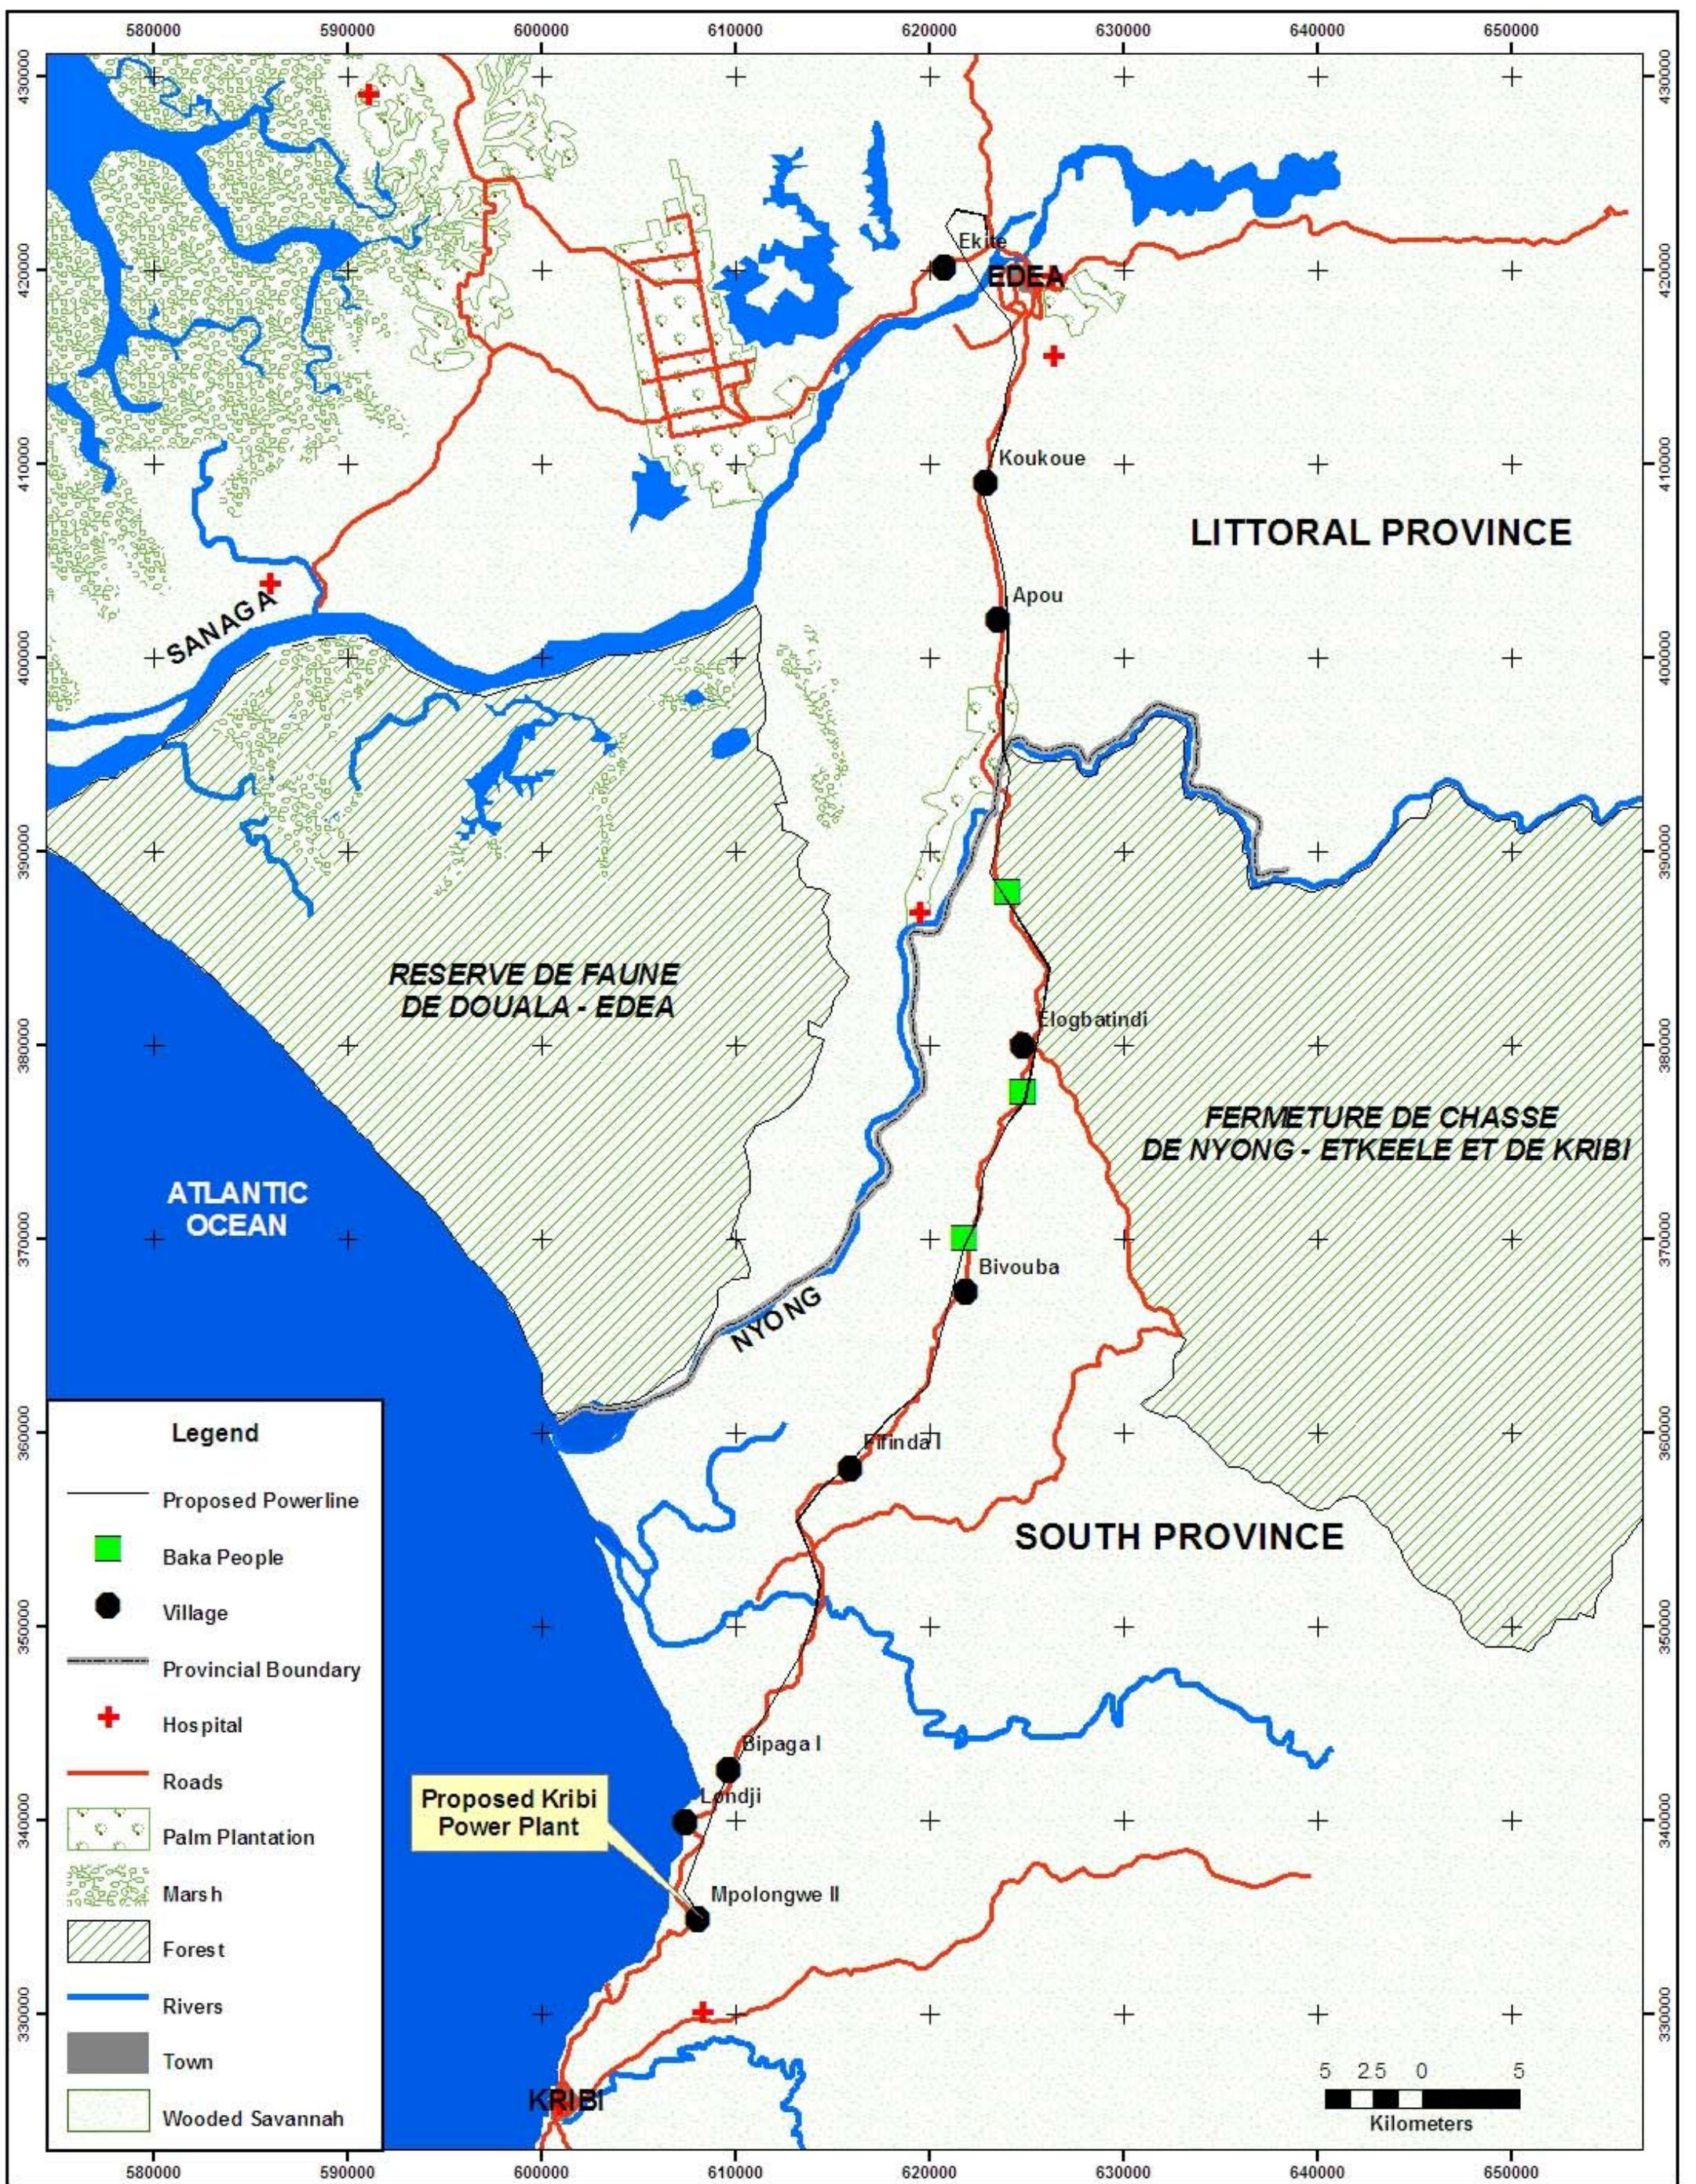

Legend

-  Proposed Powerline
-  Baka People
-  Village
-  Provincial Boundary
-  Hospital
-  Roads
-  Palm Plantation
-  Marsh
-  Forest
-  Rivers
-  Town
-  Wooded Savannah

Proposed Kribi Power Plant

 


FIGURE 1b - DETAILED LOCATION PLAN

UTM WGS 1984 ZONE 32N

AES SONEL KRIBI POWER PROJECT

RESSETLEMENT ACTION PLAN

Drawing Number
D115301_Fig 1.2

Scale at A3 : 1:300,000

DrwNGA

App PN

Rev

Chk

Date 31/08/07

Date



www.scottwilson.com

Figure 1c Example of AES Sonel Survey Map End of Power Line Near Edea

